

KEY TO INSTRUMENTS USED

Symbol Key		
	ADB Lighting C103	12
	ADB Lighting C203	5
	ADB Lighting F101	10
	ADB Lighting F201	2
	ETC Source4 19deg 750W	5
	ETC Source4 26deg 750W	8
	ETC Source4 50deg 750	4
	ETC Source4 36deg 750W	8
	Robert Juliat 310 HF Fresnel	4
	Robert Juliat 611 SX	6
	Robert Juliat 613 SX	16
	Robert Juliat 614 SX	12
MOVING LIGHTS		
	MAC TW1	4
	ETC Revolution	4
ACCESSORIES		
	4-Panel Barn Door	18
	7.5in 4 Leaf Barn Door	10

TYPICAL UNIT:

COLOUR	GOGO	UNIT NUMBER	CHANNEL NUMBER



AUTUMN OPERA SCENES

LIGHTING: MATT HOCKLEY
DESIGN: ANNA REID

THIS DRAWING REPRESENTS DESIGN INTENT AND CONCEPT ONLY. THE DESIGNER AND ASSOCIATES ARE RESPONSIBLE FOR VISUAL ASPECTS OF THIS PRODUCTION, AND ALL SPECIFICATIONS PROVIDED RELATE SOLELY TO THE APPEARANCE OF THE LIGHTING AND NOT MATTERS OF ELECTRICAL OR STRUCTURAL SOUNDNESS AND/OR SAFETY. THE IMPLEMENTATION OF THIS DESIGN MUST COMPLY WITH THE MOST STRINGENT APPLICABLE LOCAL SAFETY AND FIRE CODES. THE DESIGNER IS NOT QUALIFIED TO DETERMINE ELECTRICAL OR STRUCTURAL APPROPRIATENESS OF THE DESIGN AND WILL NOT ASSUME RESPONSIBILITY FOR DAMAGES RESULTING THROUGH IMPROPER ENGINEERING AND/OR IMPLEMENTATION IN THE HANDLING OF THIS LIGHTING DESIGN. THE DESIGNER AGREES TO MAKE PROMPT CORRECTING ALTERNATIONS TO ANY SPECIFICATION FOUND TO BE INCOMPATIBLE WITH PROPER FIRE AND SAFETY PRECAUTIONS.

LIGHTING BY: MATT HOCKLEY



E: MATTHEWHOCKLEY@BTINTERNET.COM


DRAWN: MATT HOCKLEY

DRAWING: V3 REV: 08/11/19

LIGHTING LAYOUT

SCALE: 1:25 PAPER: 1:25@A0

NOTES:
 - UNI-STRUT HEIGHTS ARE TBC.
 - ANY COLOUR NOT ON PLAN IS TBC
 - FINAL GOGO CALL TBC

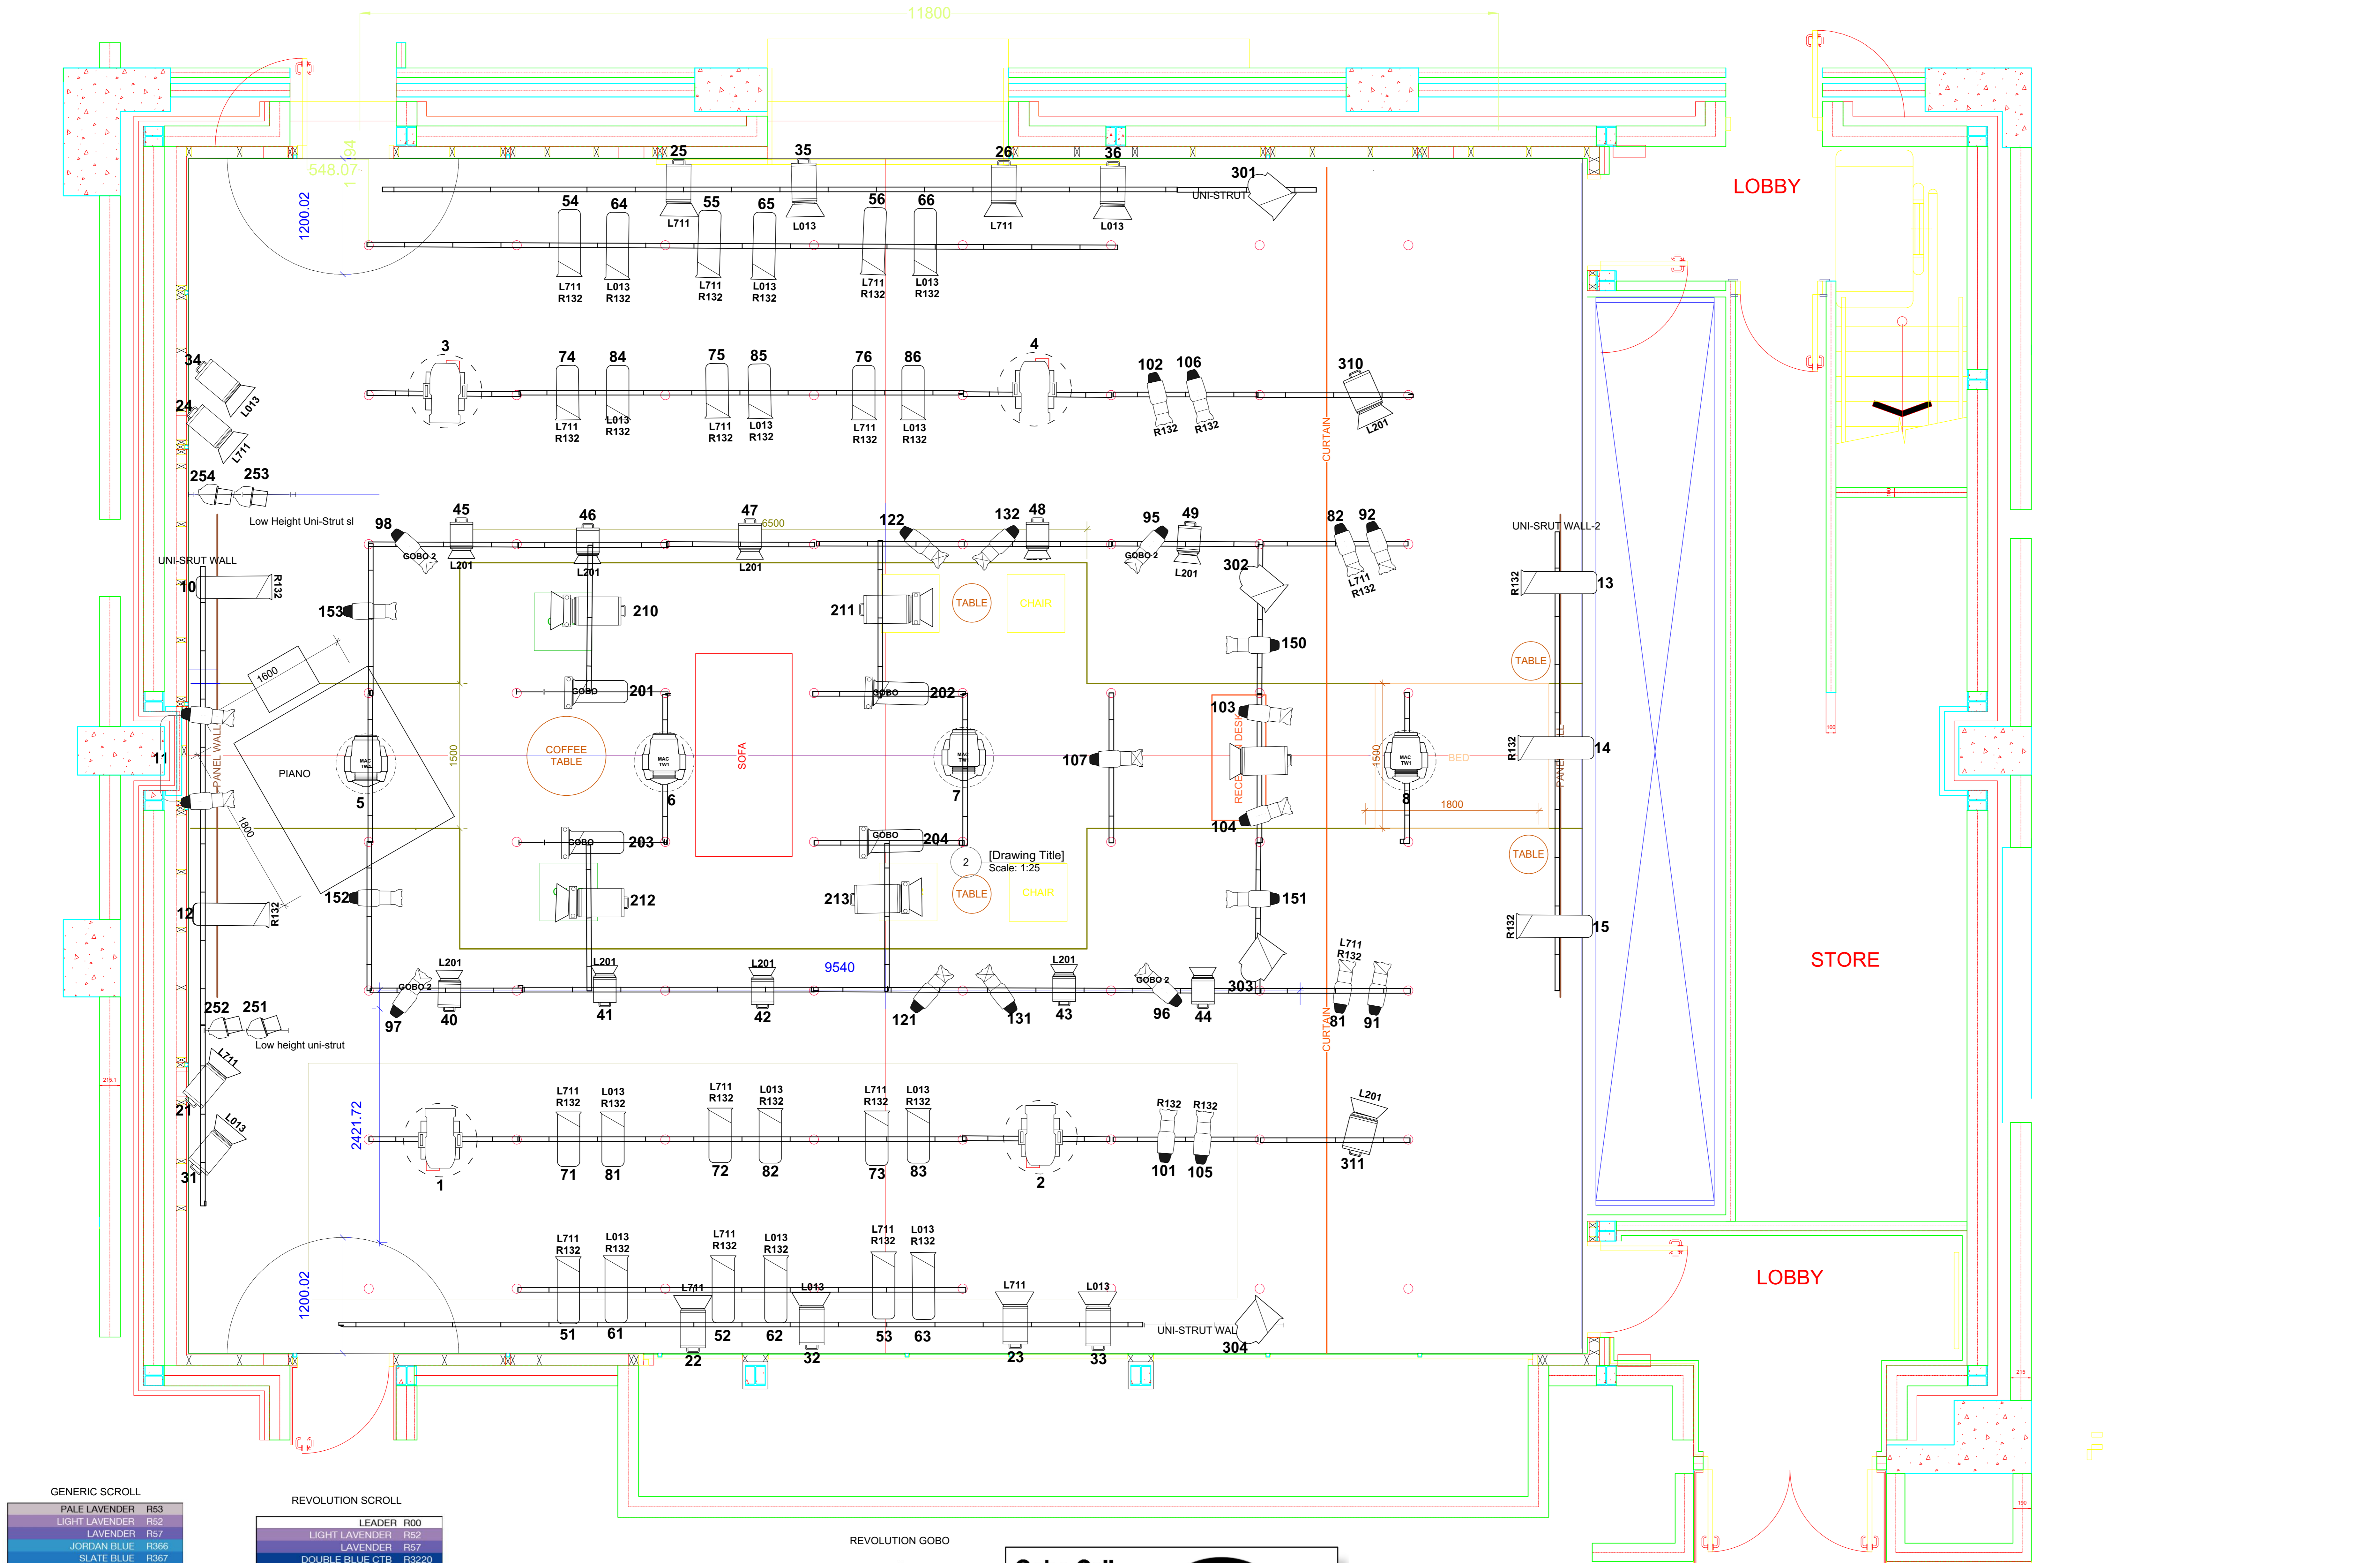

GENERIC SCROLL



PALE LAVENDER	R53
LIGHT LAVENDER	R52
LAVENDER	R57
JORDAN BLUE	R366
SLATE BLUE	R367
SAPPHIRE BLUE	R303
SURPRISE BLUE	R82
TRUDY BLUE	R78
THEATRE BOOSTER 1	R371
THEATRE BOOSTER 2	R372
THEATRE BOOSTER 3	R373
THEATRE BOOSTER 3	NC L130
BASTARD AMBER	R02
PALE APRICOT	R304
PALE AMBER GOLD	R09
MEDIUM STRAW	R14
DEEP AMBER	R22
LIGHT RED	R26
LIGHT RELIEF YELLOW	R313
MEDIUM PURPLE	R49
CHERRY ROSE	R332
BRIGHT BLUE	R79
DARK YELLOW GREEN	R90
MEDIUM RED	R27

REVOLUTION SCROLL

LEADER	R00
LIGHT LAVENDER	R52
LAVENDER	R57
DOUBLE BLUE CTB	R320
BRIGHT BLUE	R79
SLATE BLUE	R367
TRUDY BLUE	R78
THEATRE BOOSTER 1	R371
THEATRE BOOSTER 2	R372
THEATRE BOOSTER 3	R373
THEATRE BOOSTER 3	NC L130
BASTARD AMBER	R02
PALE APRICOT	R304
PALE AMBER GOLD	R09
MEDIUM STRAW	R14
DEEP AMBER	R22
MEDIUM PINK	R56
CHERRY ROSE	R332
LIGHT RED	R26
LIGHT RELIEF YELLOW	R313
PEACHES	R23
TRAILER	R00

Colour Call

	R09
	L013
	L711
	L201

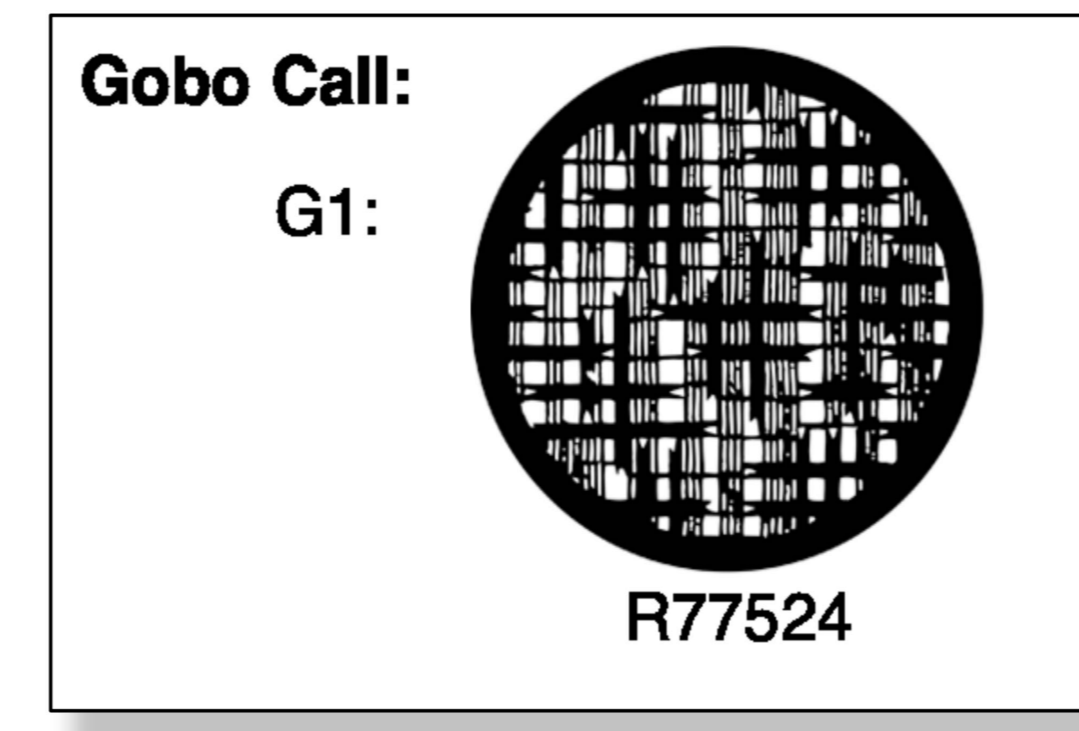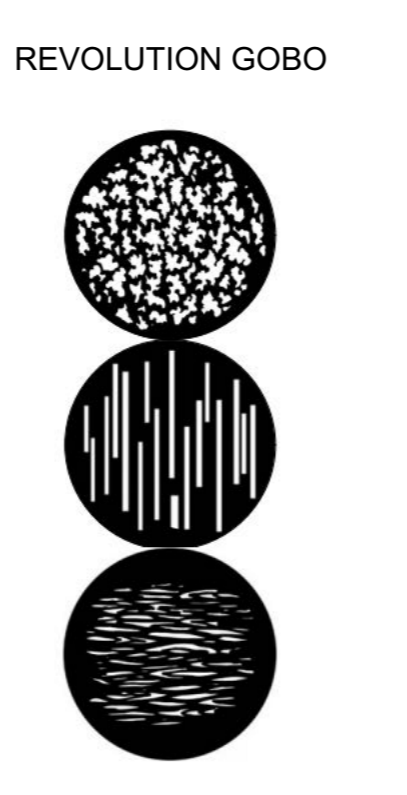

Pendant Channels SL - SR

401
402
403
404
405
406
407
408