


REVOLUTION

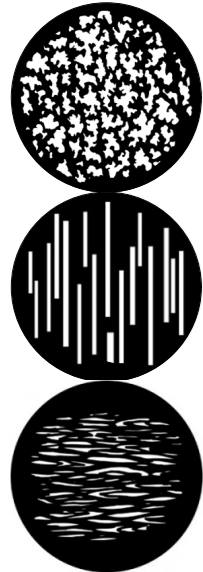


REVOLUTION SCROLL

LEADER	R00
LIGHT LAVENDER	R52
LAVENDER	R57
DOUBLE BLUE CTB	R3220
BRIGHT BLUE	R79
SLATE BLUE	R367
TRUDY BLUE	R78
THEATRE BOOSTER 1	R371
THEATRE BOOSTER 2	R372
THEATRE BOOSTER 3	R373
NC	L130
BASTARD AMBER	R02
PALE APRICOT	R304
PALE AMBER GOLD	R09
MEDIUM STRAW	R14
DEEP AMBER	R22
MEDIUM PINK	R36
CHERRY ROSE	R332
LIGHT RED	R26
LIGHT RELIEF YELLOW	R313
PEA GREEN	R86
TRAILER	R00

GENERIC SCROLLER

PALE LAVENDER	R53
LIGHT LAVENDER	R52
LAVENDER	R57
JORDAN BLUE	R366
SLATE BLUE	R367
SAPPHIRE BLUE	R383
SURPRISE BLUE	R82
TRUDY BLUE	R78
THEATRE BOOSTER 1	R371
THEATRE BOOSTER 2	R372
THEATRE BOOSTER 3	R373
NC	L130
BASTARD AMBER	R02
PALE APRICOT	R304
PALE AMBER GOLD	R09
MEDIUM STRAW	R14
DEEP AMBER	R22
LIGHT RED	R26
LIGHT RELIEF YELLOW	R313
MEDIUM PURPLE	R49
CHERRY ROSE	R332
BRIGHT BLUE	R79
DARK YELLOW GREEN	R90
MEDIUM RED	R27

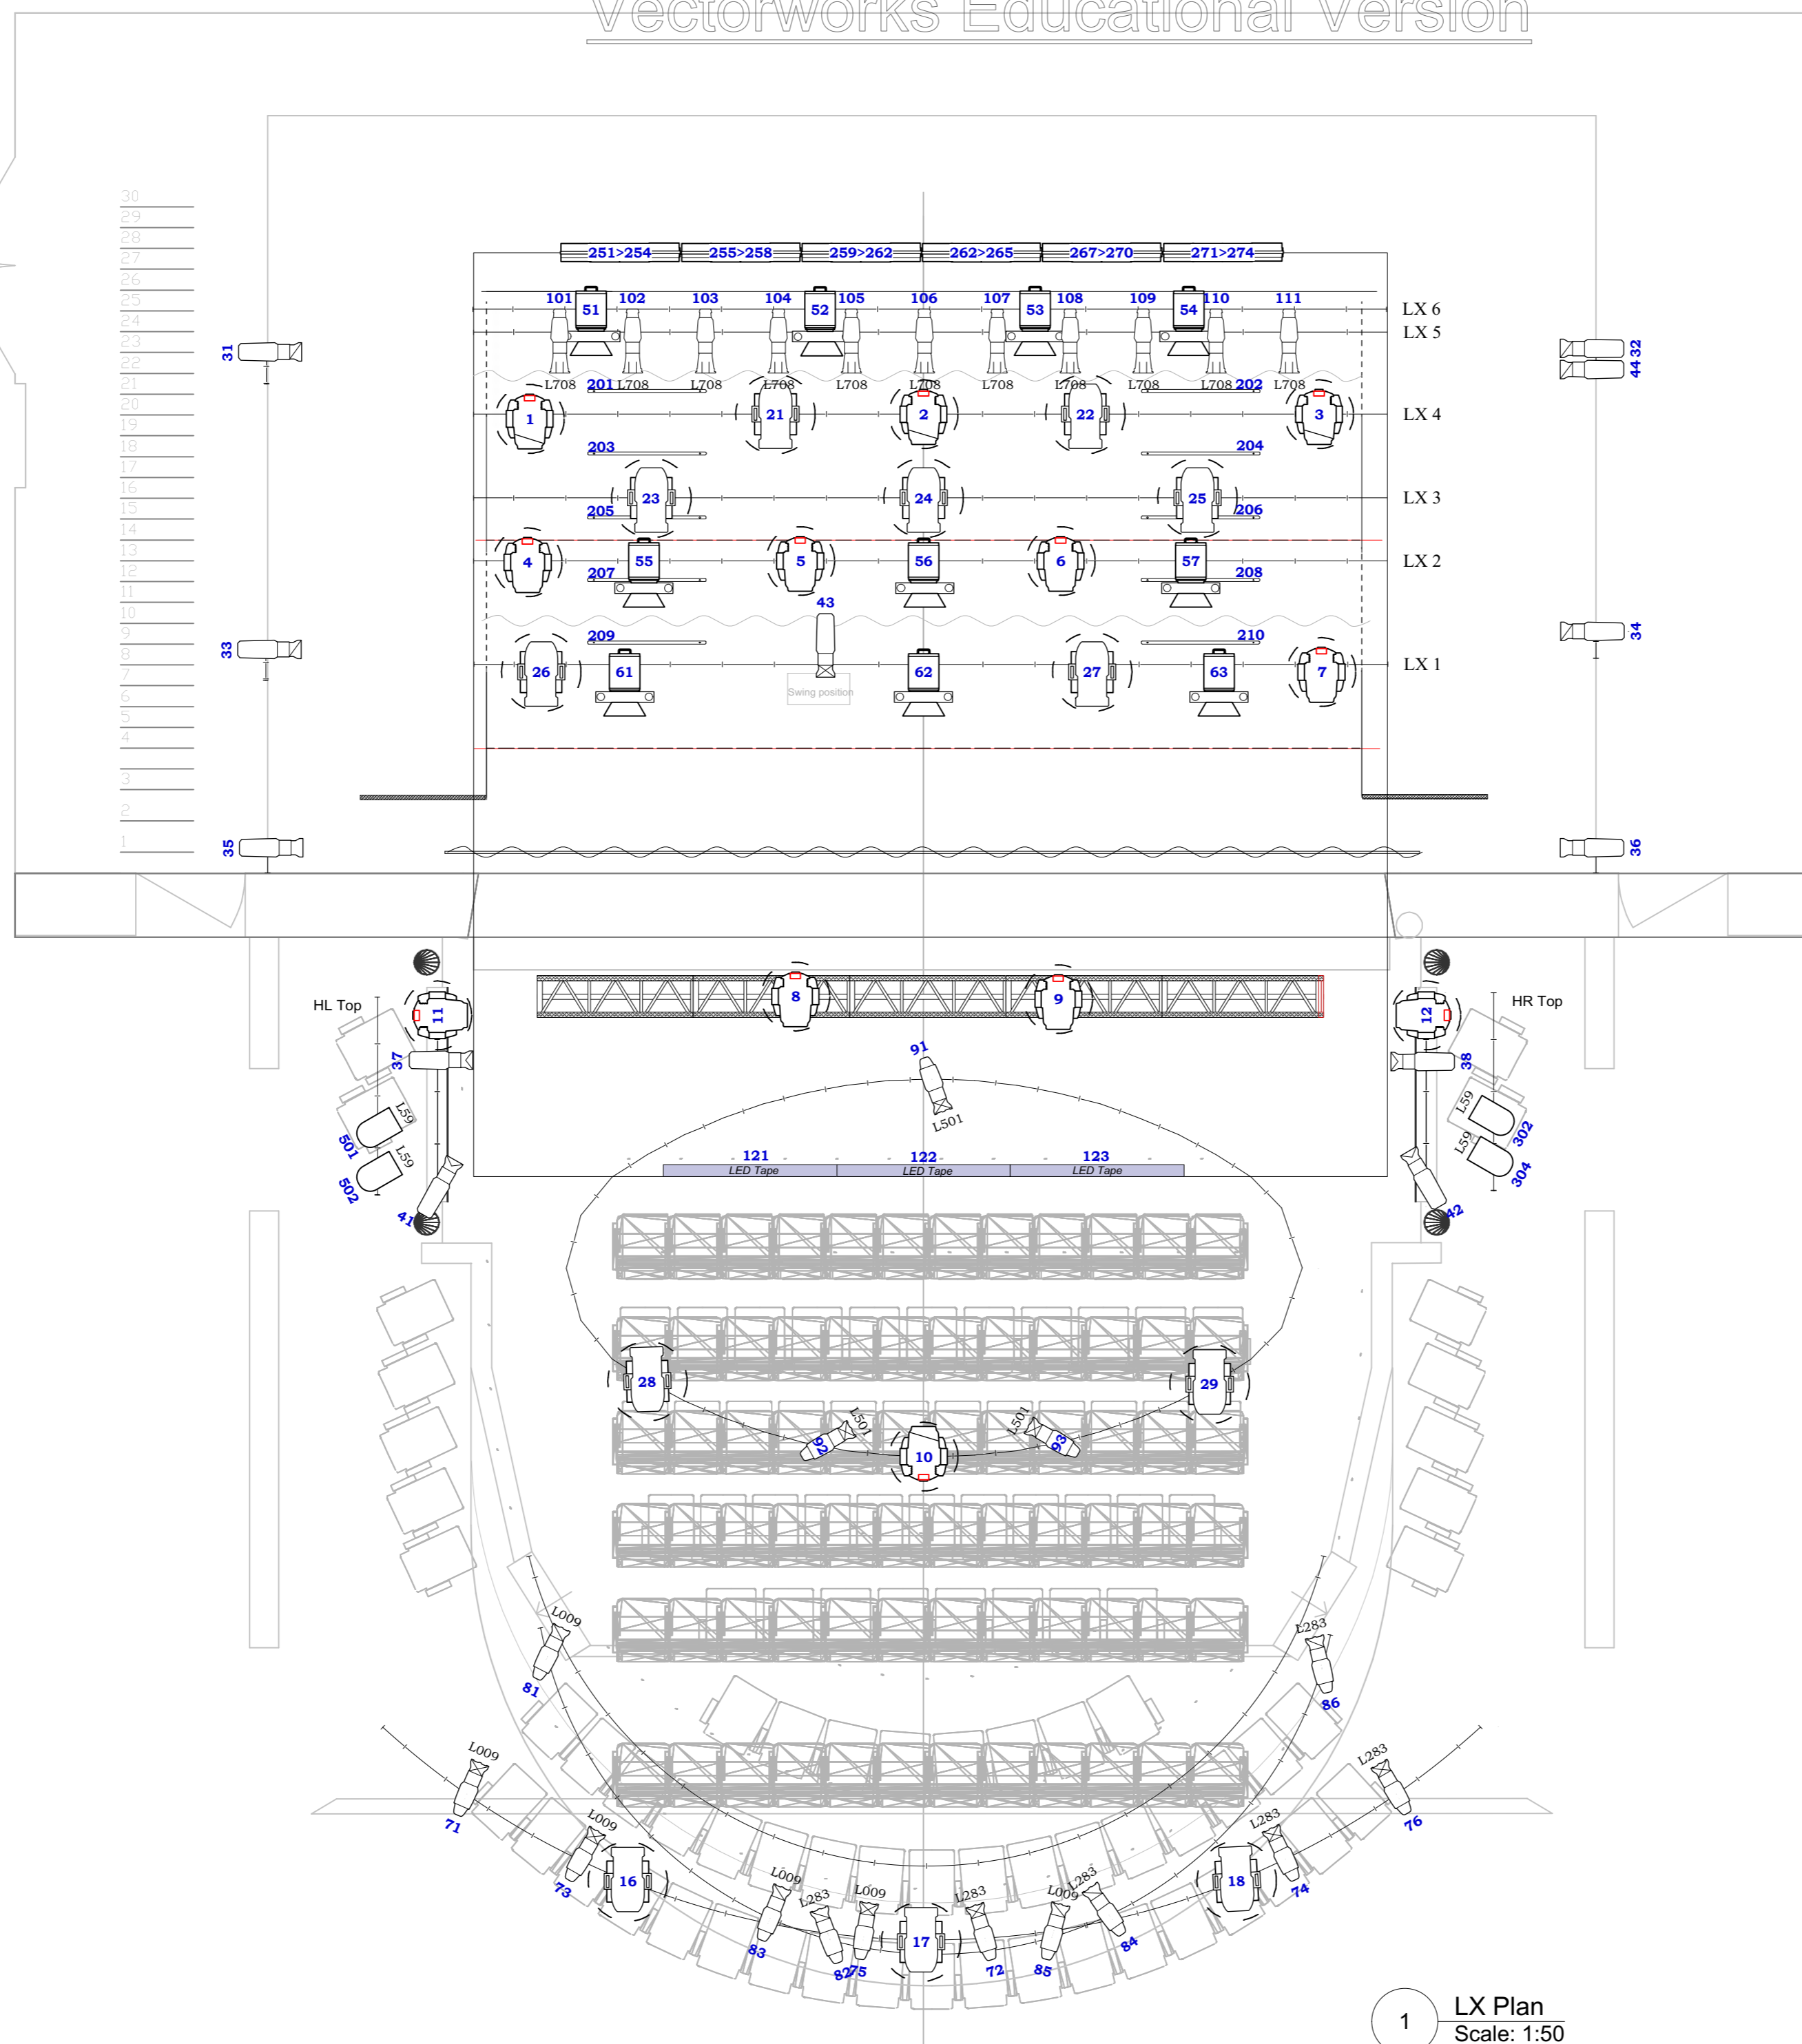

	ETC Source4 14deg @ 575 w	11
	ETC CE Source4 19deg @ 575w	9
	ETC CE Source4 26deg @ 575w	6
	ADB Lighting F201 @ 2kw	10
	Selecon LUI CYC 4	6
	USITT PAR64-MFL @ 1kw	4
	ETC Source4 LED 19deg @ 140w	1
	ETC Source4 LED 26deg @ 140w	5
	ETC Source4 LED 36deg @ 140w	2
	ETC Source4 LED 50deg @ 140w	4
	ETC Revolution @ 750w	12
	Martin MAC TW1 @ 1.233kw	8
	Martin MAC TW1 Narrow @ 1.233kw	4
	Wybron The Scroller 8 Light	10

Color	Size	Count	
	L009	159mm	6
	L59	USITT PAR64-MFL	4
	L283	159mm	6
	L501	159mm	3
	L708	191mm	11

- Notes:
1. All Gallery Front units, Egg S4s, Advance Bar and FOH Box TW1s have top hats
  2. 1 MTG Atmosphere Hazer, Channel 500
  3. Channel 43 is derigged US of LX1

Director: Abigail Graham  
 Designer: Sarah Beaton  
 Lighting Designer: Sofia Di Lorenzo  
 Production Electrician: Matt Dean

Lighting Plan V7  
 Date: 30/01/20  
 Scale: 1:50 @ A2  
 Earthquakes in London  
 Milton Court Theatre  
 February 2020



Earthquakes in London