 
 



 
 






 
 







 
KEY TO INSTRUMENTS USED

-  ETC CE Source4 26deg
-  ADB Lighting C203
-  ADB Lighting F101
-  ADB Lighting F201

-  Chroma Q Color Force 72


-  ETC CE Source4 19deg
-  ETC CE Source4 36deg
-  ETC CE Source4 50deg
-  ETC CE Source4 Zoom 25-50deg
-  ETC Source4 50deg
-  ETC Source4 LED 36deg
-  ETC Source4 LEDLS 26deg
-  ETC Source4 PAR MFL
-  USITT PAR64-MFL
-  Jthomas Pixelline 1044
-  Robert Juliat 614 SX
-  Robert Juliat Le Bison
-  Fresnel
-  Selecon HUI Flood 3

- Moving Lights**
-  ETC Revolution
-  MAC TW1
-  Martin MAC TW1 Narrow
-  Martin MAC III Performance
-  JB Lighting A 12

- Accessories**
-  Iris
-  7.5in Top Hat
-  Wybron The Scroller 7.5"

TYPICAL UNIT:

- COLOUR**
- GOBO**
- UNIT NUMBER**
- CHANNEL NUMBER**

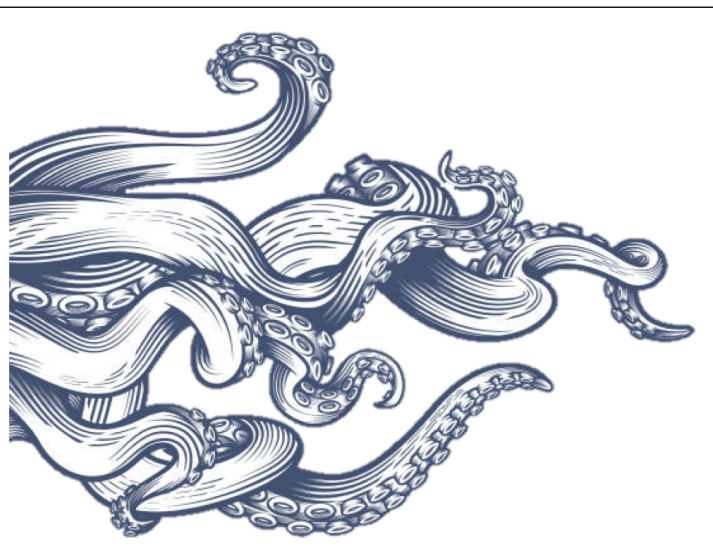

LA FEDELTÀ PREMIATA

LIGHTING: DAVID HOWE
 DESIGN: ADRIAN LINFORD

THIS DRAWING REPRESENTS DESIGN INTENT AND CONCEPT ONLY. THE DESIGNER AND ASSOCIATES ARE RESPONSIBLE FOR VISUAL ASPECTS OF THIS PRODUCTION, AND ALL SPECIFICATIONS PROVIDED RELATE SOLELY TO THE APPEARANCE OF THE LIGHTING AND NOT MATTERS OF ELECTRICAL OR STRUCTURAL SOUNDNESS AND/OR SAFETY. THE IMPLEMENTATION OF THIS DESIGN MUST COMPLY WITH THE MOST STRINGENT APPLICABLE LOCAL, STATE AND FIRE CODES. THE DESIGNER IS NOT QUALIFIED TO DETERMINE ELECTRICAL OR STRUCTURAL APPROPRIATENESS OF THE DESIGN AND WILL NOT ASSUME RESPONSIBILITY FOR DAMAGES RESULTING THROUGH IMPROPER ENGINEERING AND/OR IMPLEMENTATION IN THE HANDLING OF THIS LIGHTING DESIGN. THE DESIGNER AGREES TO MAKE PROFIT CORRECTING ALTERNATIONS TO ANY SPECIFICATION FOUND TO BE INCOMPATIBLE WITH PROPER FIRE AND SAFETY PRECAUTIONS.

LIGHTING BY:
DAVID HOWE
 M: +447973 631494
 E: DAVID.DHL.BIZ@GMAIL.COM



DRAWN: MATT HOCKLEY: 07714588882
 MATTHEWHOCKLEY@BTINTERNET.COM

DRAWING: 1 REV: 11/10/19


LIGHTING LAYOUT


SCALE: 1:50 PAPE 1:50 @ AO


SHEET:

1

GOBO CALL:

G1:  **R77524**

G3:  **77903**

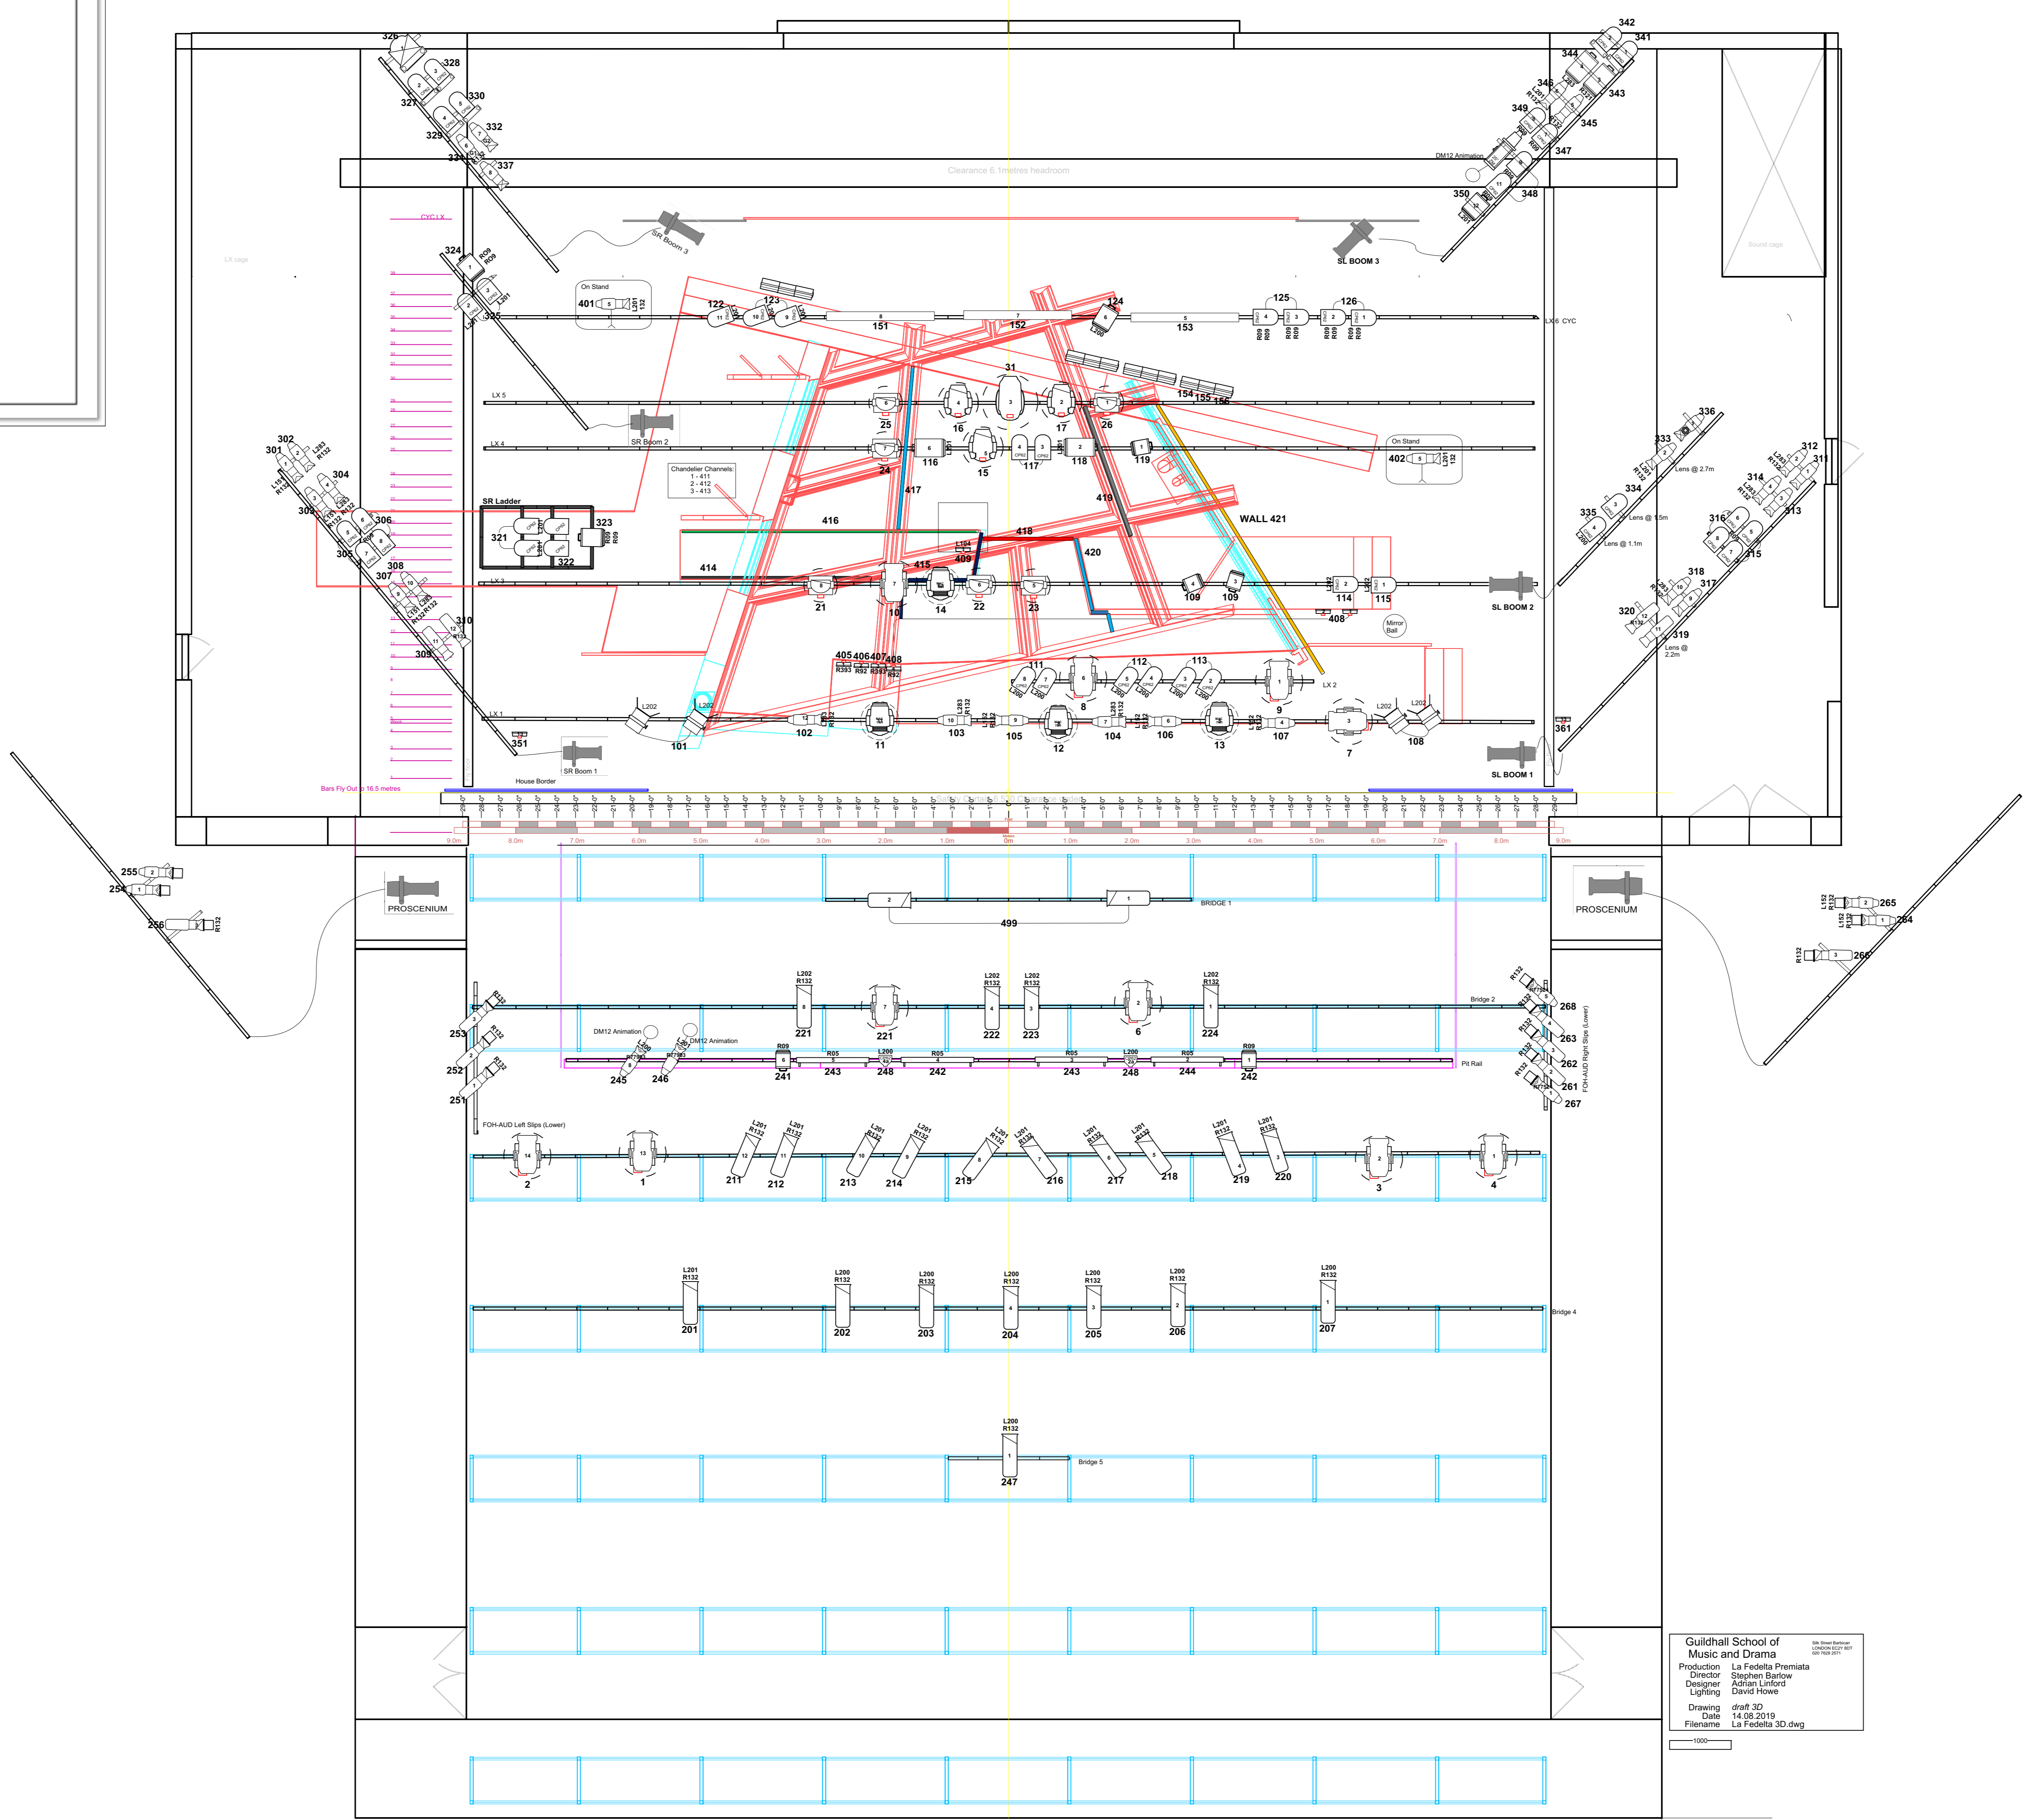

Guildhall School of Music and Drama
 Production: La Fedeltà Premiata
 Director: Stephen Barlow
 Designer: Adrian Linford
 Lighting: David Howe
 Drawing: draft 3D
 Date: 14.08.2019
 Filename: La Fedeltà 3D.dwg